


# SITE PLAN

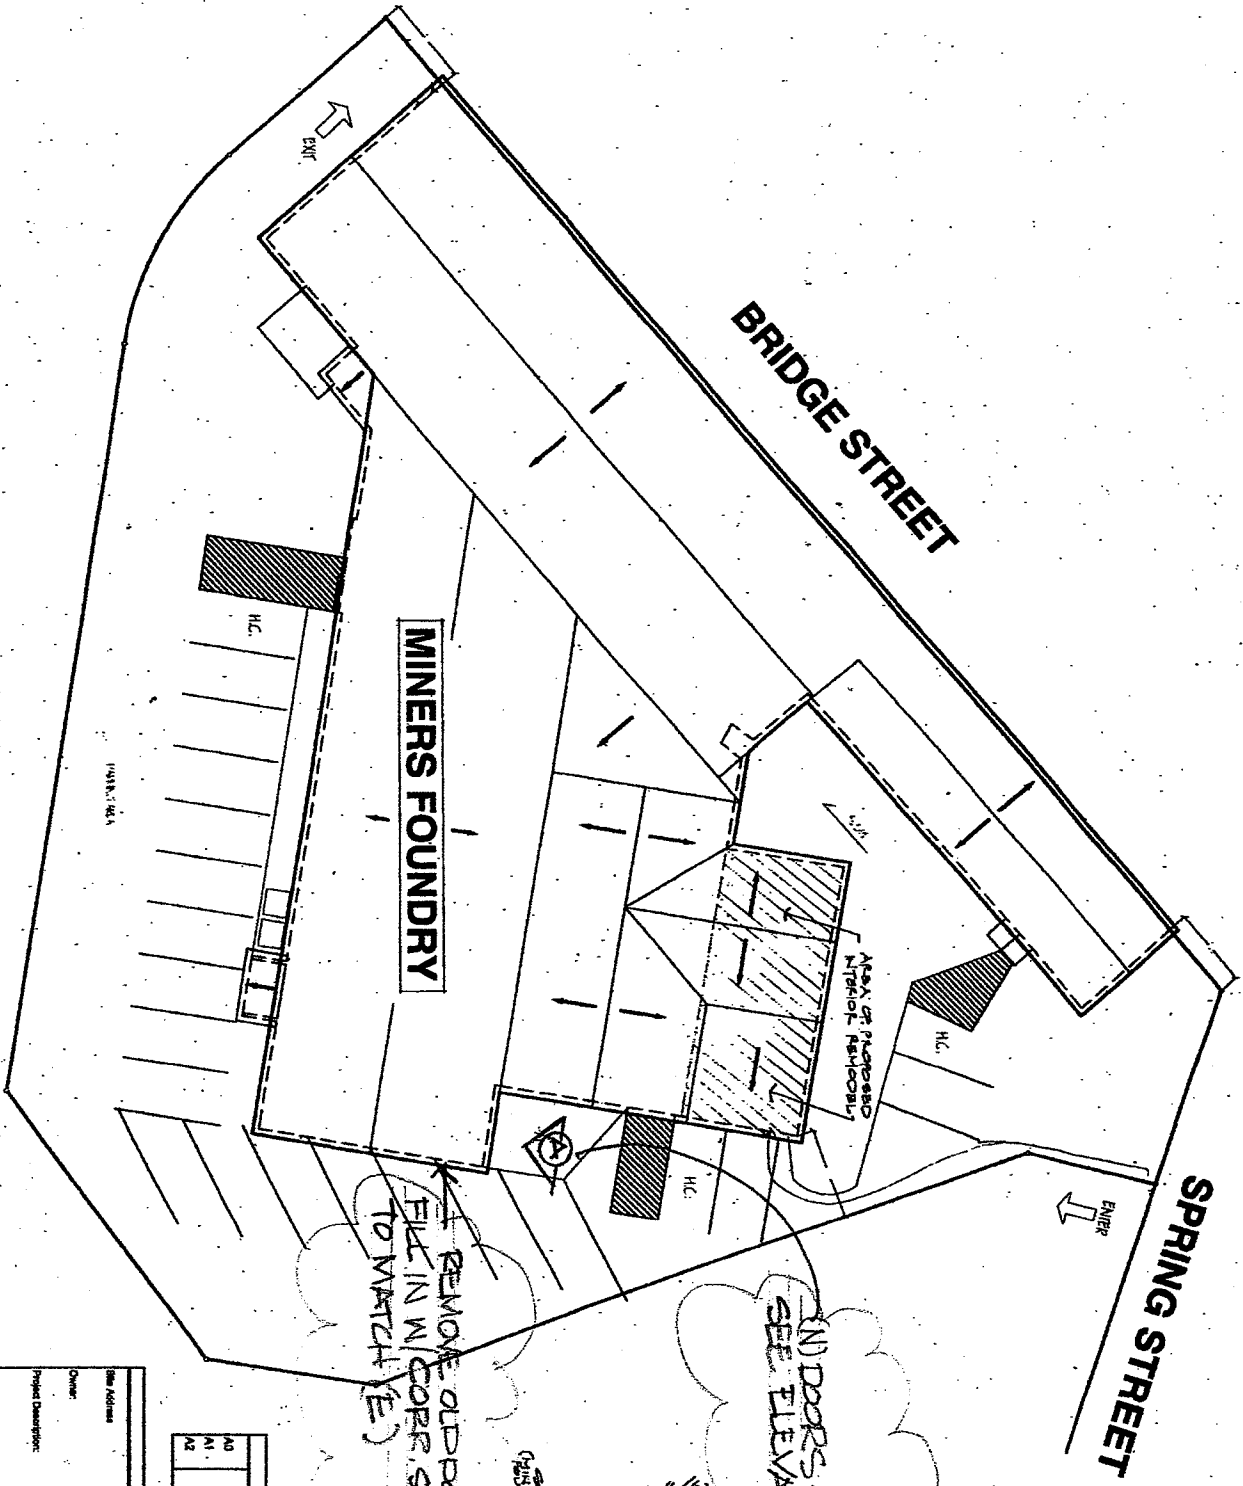

SCALE 1" = 10'-0"

<b>PROJECT INFORMATION</b>	
Site Address	325 Spring Street Nevada City, NV
Owner	Miners Foundry
Project Description	Remodel of existing space to include: Public Restroom & Conference Room Addition of upper floor office space
Architect	DAUGERT DESIGNS 11728/01 7-5-07
Plan Level: (existing)	1st fl.
Upper Level: (additional)	2nd fl.
Total Conditions:	1-5-07

<b>SHEET INDEX</b>	
A0	SITE PLAN
A1	FLOOR PLANS & INT. DETAILS
A2	ELECTRICAL PLANS & EXT. ELEVATION

## LOCATION MAP

REMOVE OLD DOORS, FILL IN W/ CORR. SIDING, TO MATCH (E)

(IN) DOORS - PROP. LOC. SEE ELEVATION

### REMODEL PLANS for MINERS FOUNDRY 325 SPRING STREET, NEVADA CITY

**DAUGERT  
DESIGNS**  
ARCHITECTS  
11728/01  
7-5-07

Sheet No.	A0
Date	11/28/01
Scale	1" = 10'-0"
Project No.	2004-01
Client	Miners Foundry
Architect	DAUGERT DESIGNS